


Geocellular Unit A
4m x 11m x 0.5m (dp)
Vol: 20.9m³

Geocellular Unit B
4m x 11m x 0.5m (dp)
Vol: 20.9m³

Proposed Drainage Layout
Scale 1:100

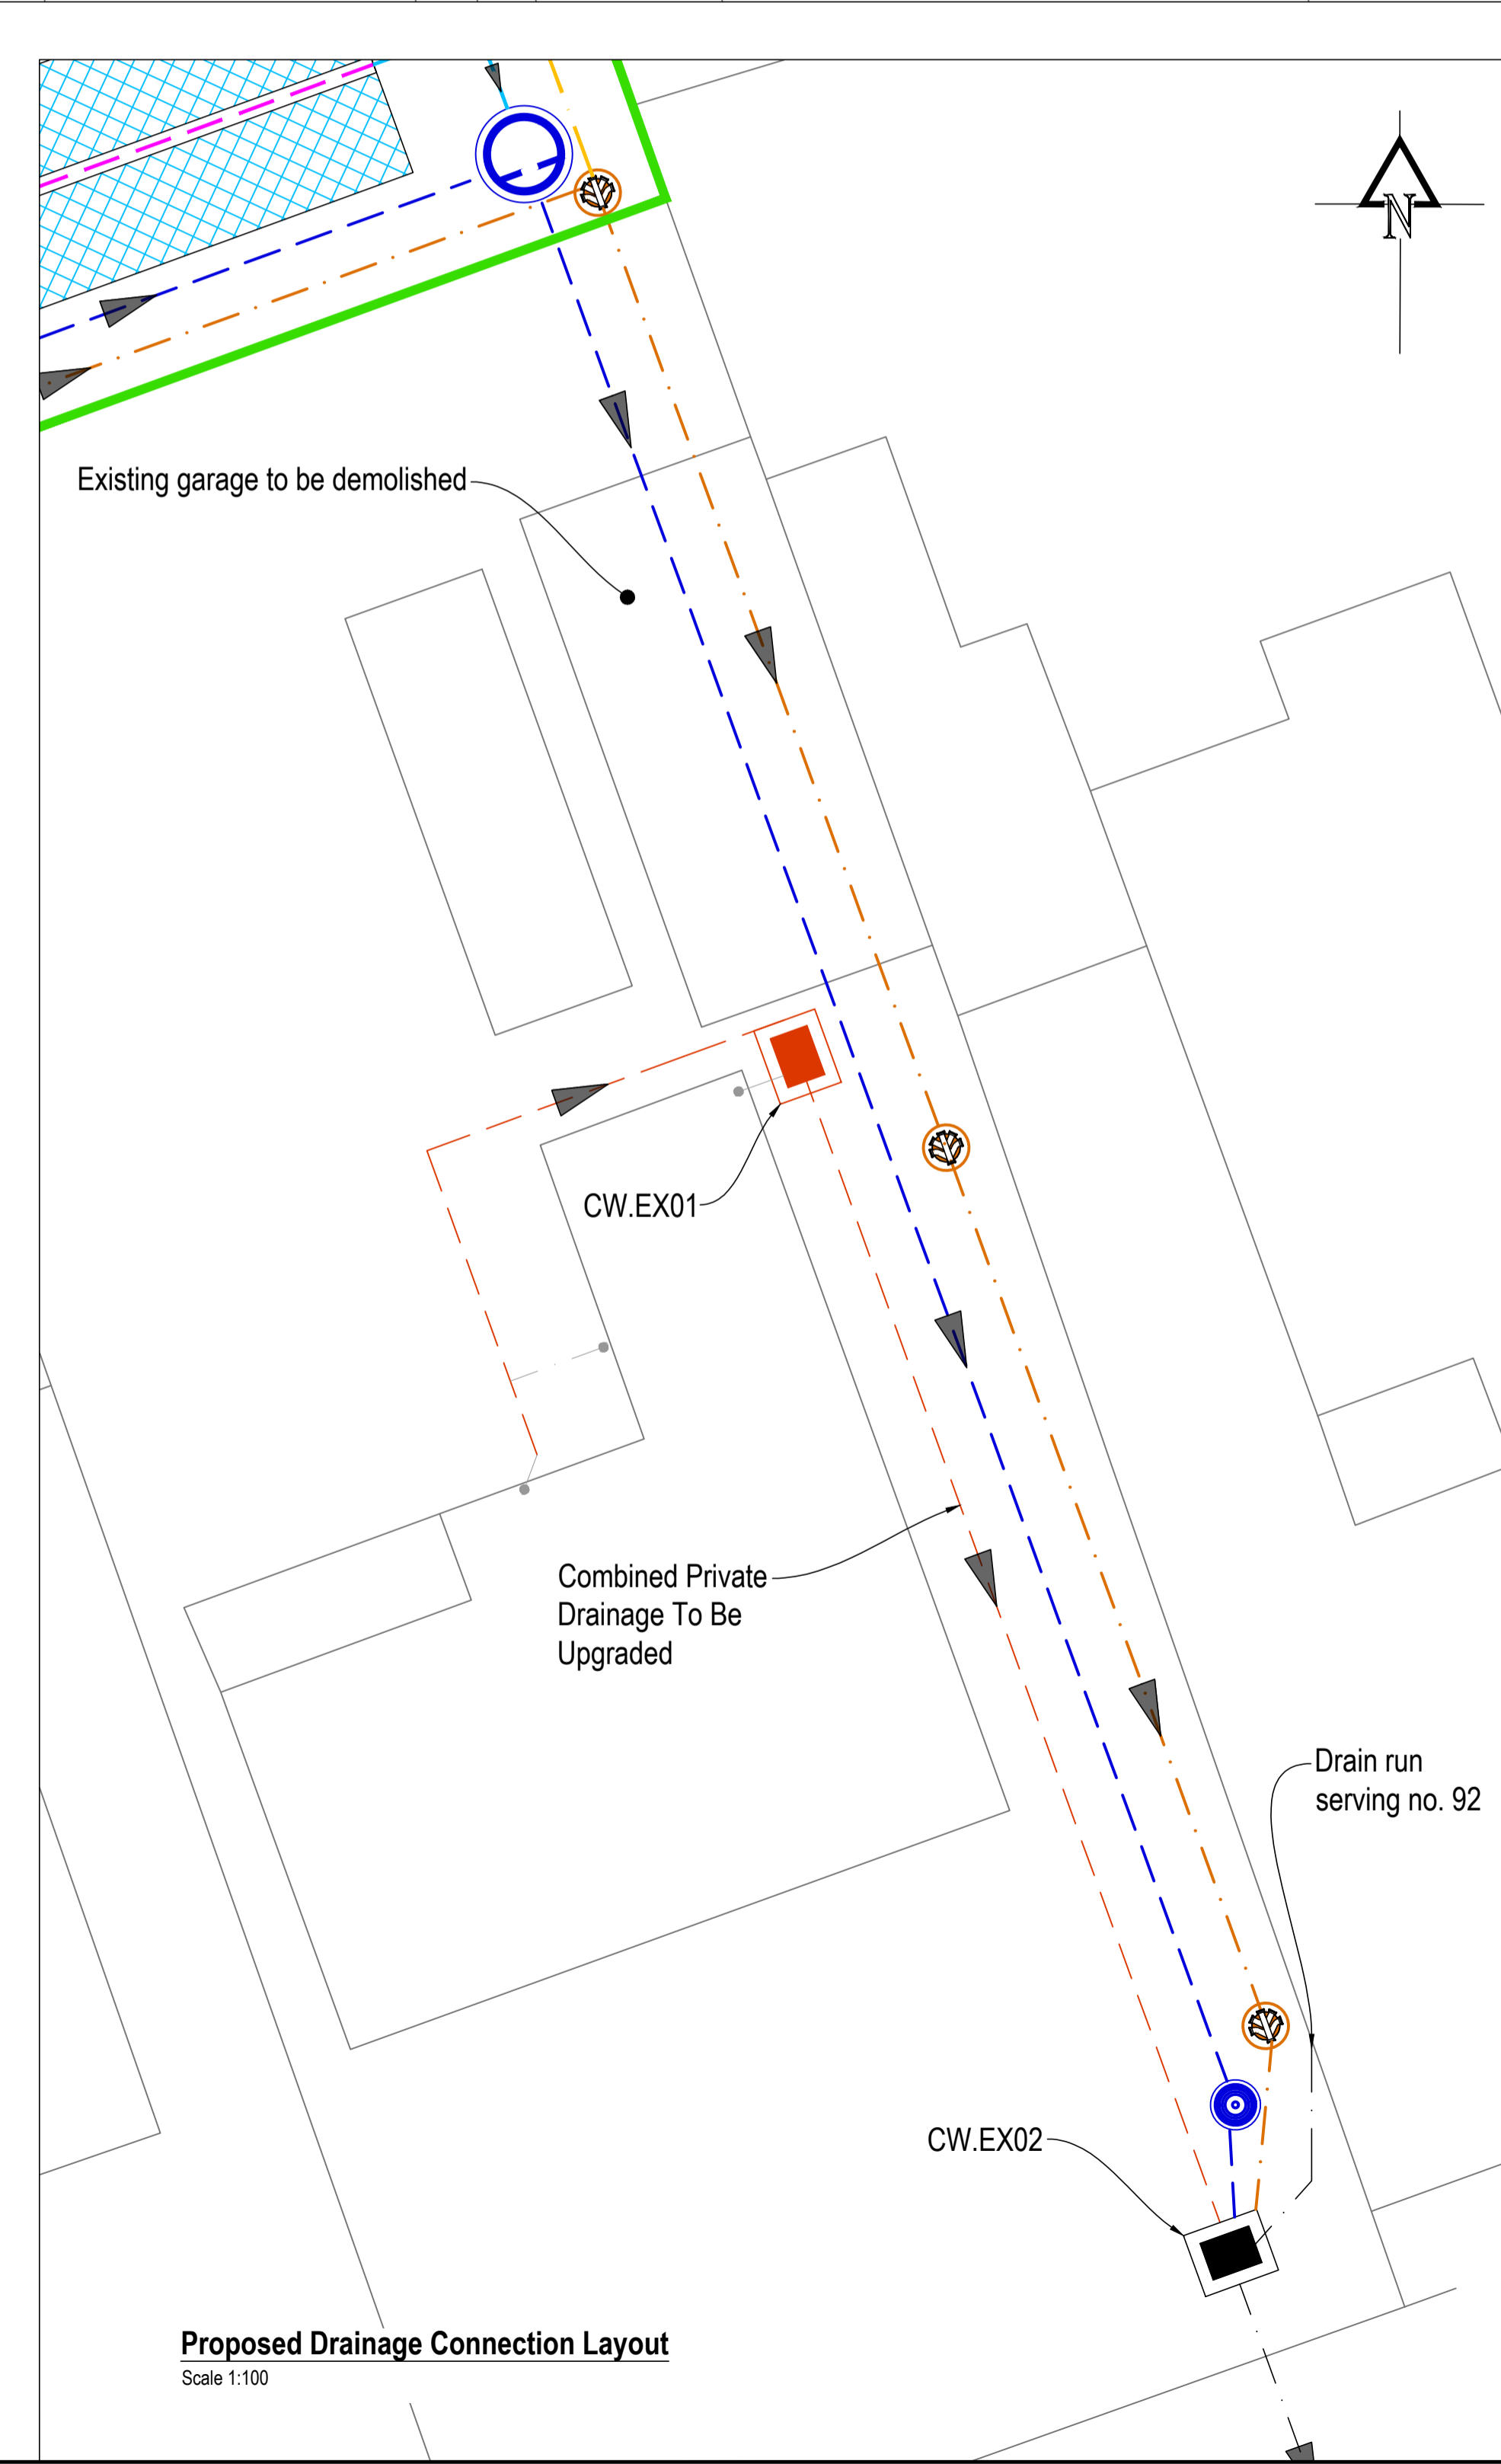

Proposed Drainage Connection Layout
Scale 1:100

Notes

- This drawing has been produced for SAB Pre-Application only and is not to be used for construction

Key

- Development Boundary
- Proposed Plot Boundary
- - - Existing Combined Drain (Private)
- - - Existing DCWW Combined Sewer/Lateral Drain
- - - Proposed Private Foul Drain
- - - Proposed Adoptable Foul Drain (DCWW)
- - - Proposed Private Surface Water Drain
- - - Proposed Private Surface Water Drain (Perforated)
- - - Proposed Adoptable Surface Water Drain (SAB)

Rev.	Date	Details	By	Chk.
Amendments				

Bear Structures
 Rugged by design
 Sophia House 28 Cathedral Road Cardiff CF11 9LJ
 United Kingdom 029 20 304 979

Project: **Land to Rear of 94 & 96 Allt-Yr-Yn Avenue Newport**

Title: **Proposed Drainage Layout**

Drawing Status: **INFORMATION**

Drawn: PC	Checked: -	Scale(s) at A1: AS SHOWN
Date: 22.03.2022	Job No: P0377	Drawing No: SK06